


REFLECTED CEILING AND LIGHTING PLAN

2

SCALE: 1/4" = 1'

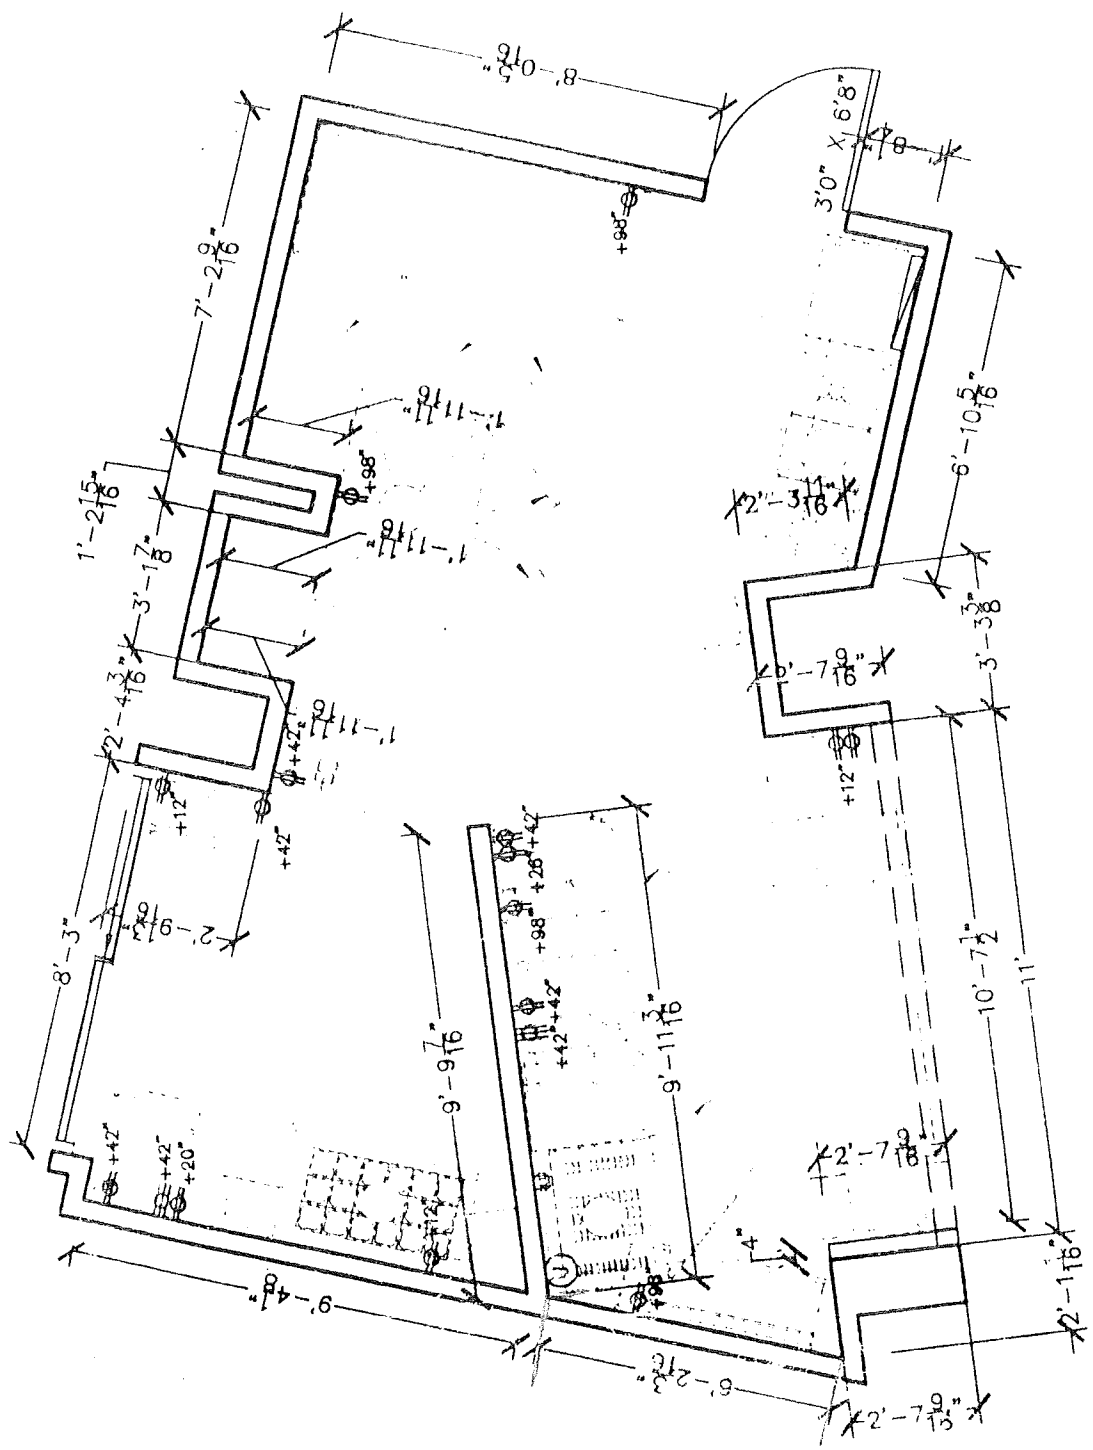

ELECTRIC AND DIMENSION PLAN

3

SCALE: 1/4" = 1'